
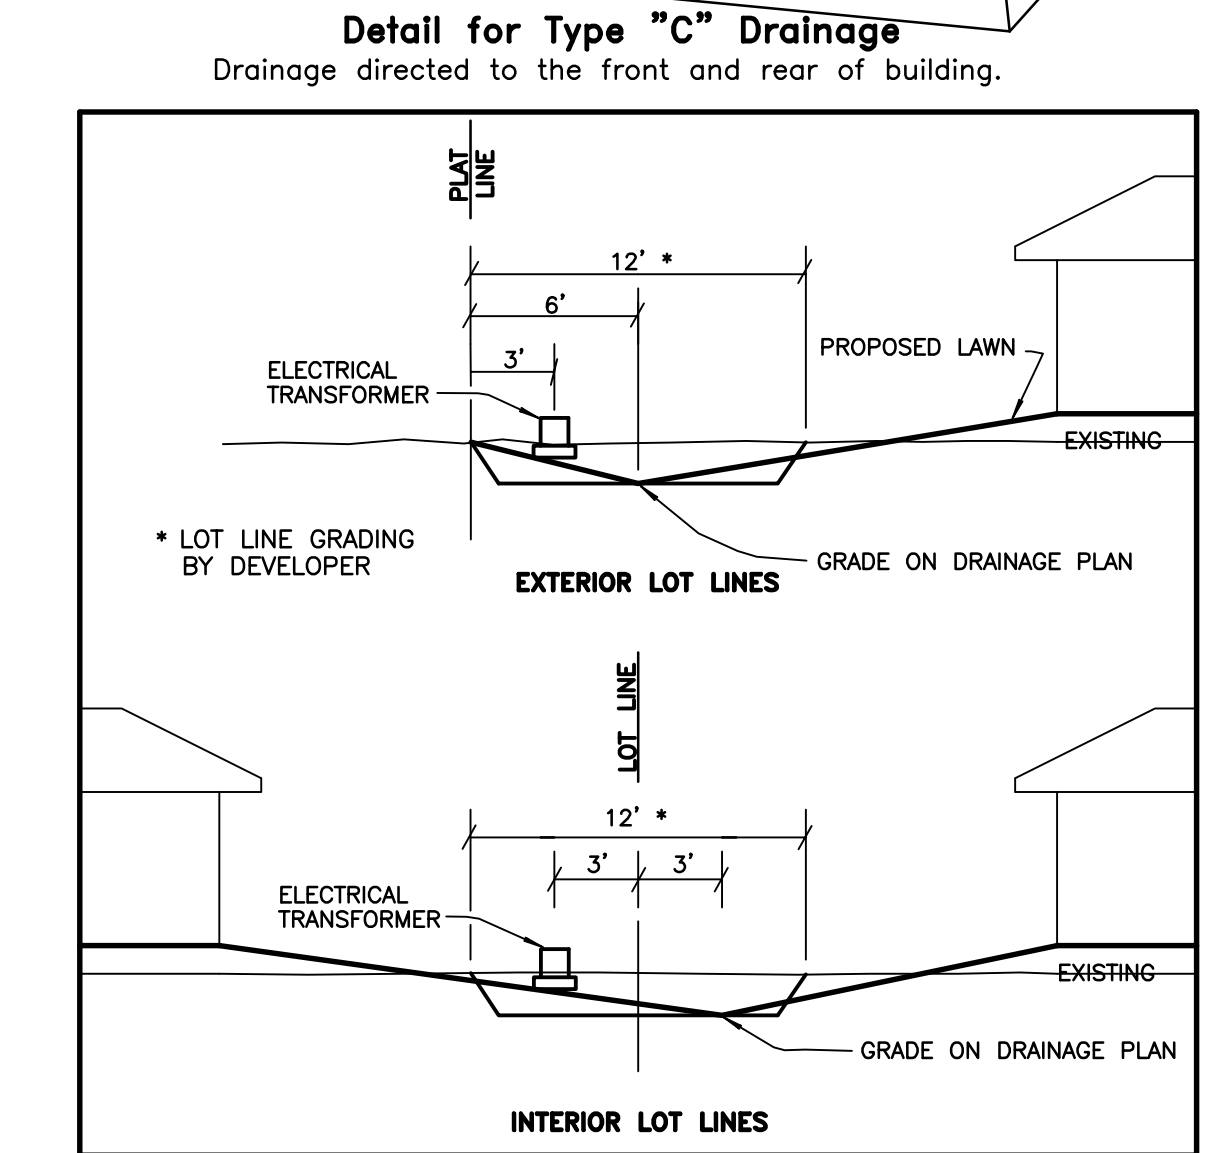
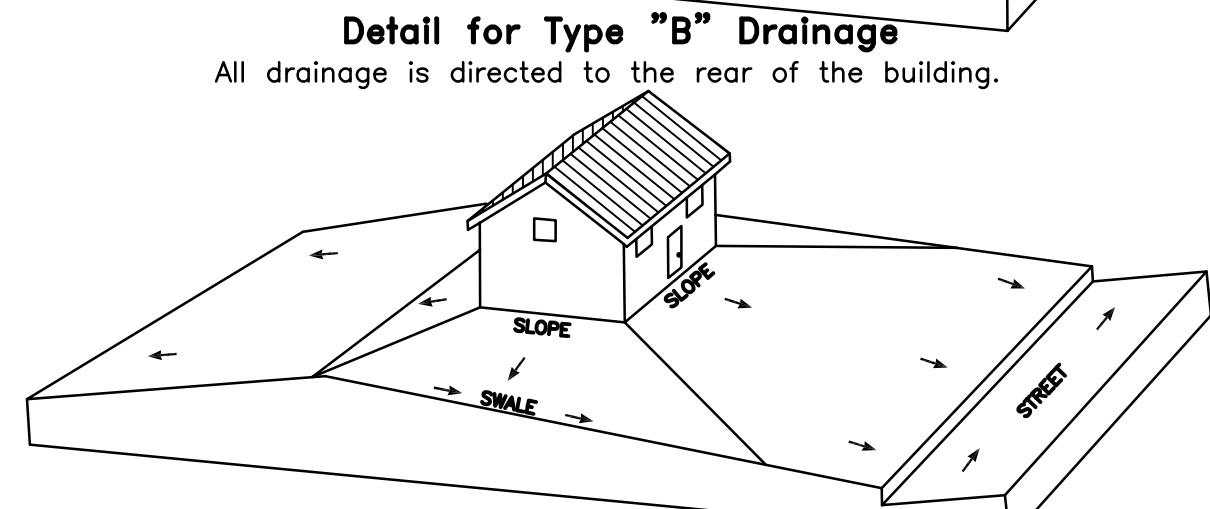
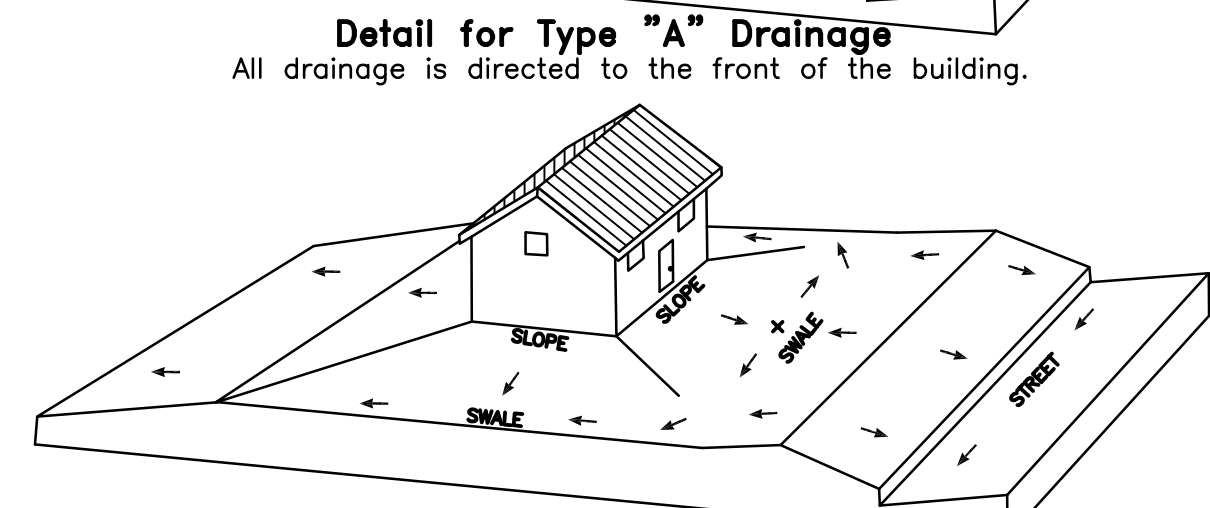
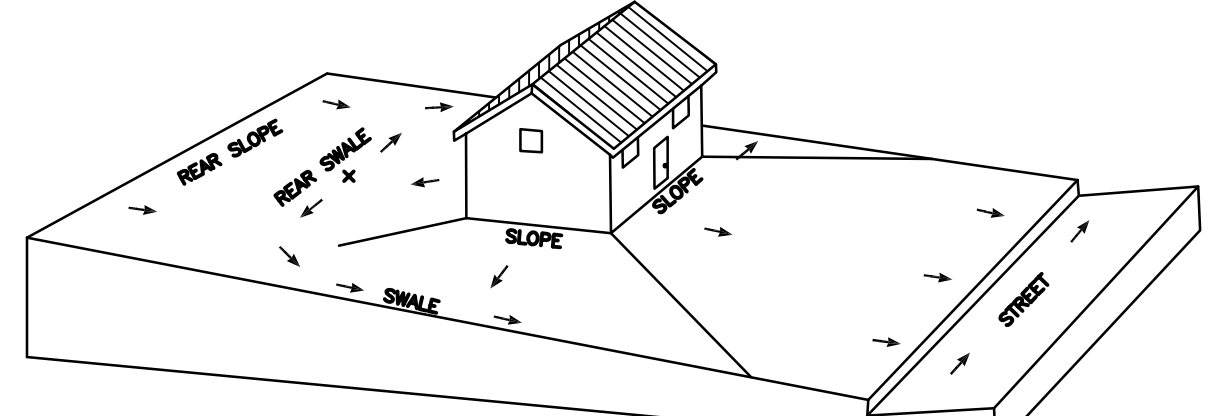
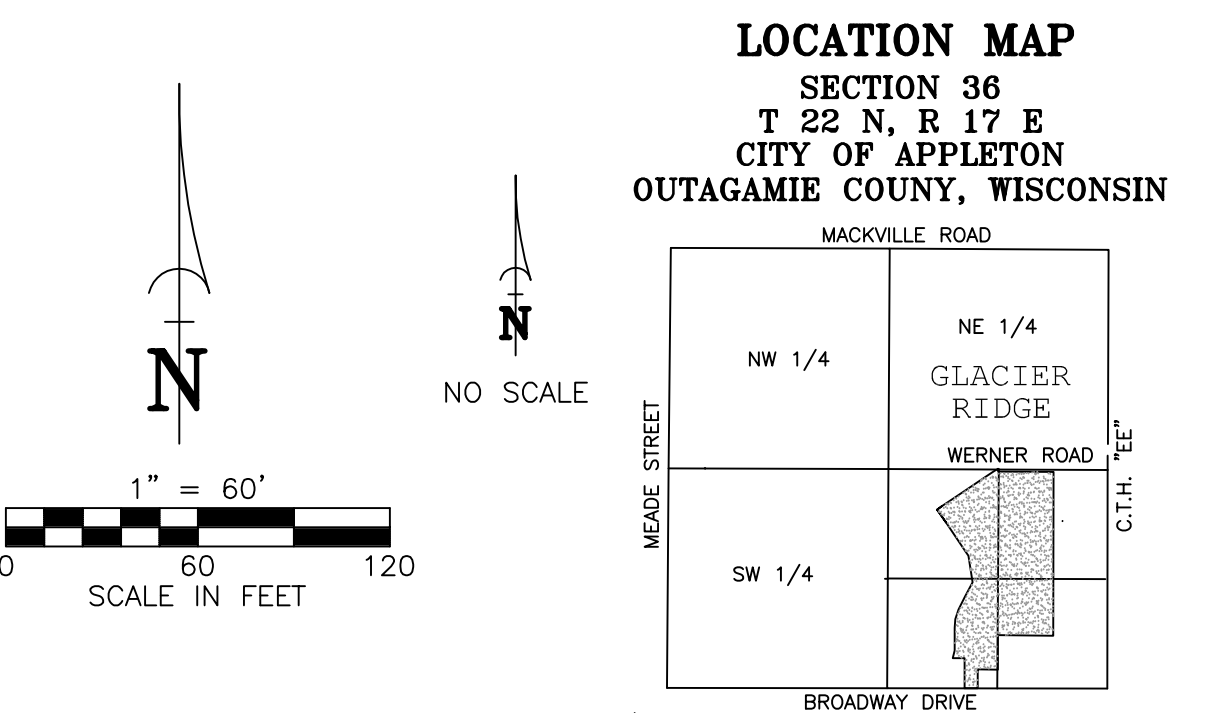


# GLACIER RIDGE (PHASE 1): FINAL DRAINAGE PLAN (SOUTH)

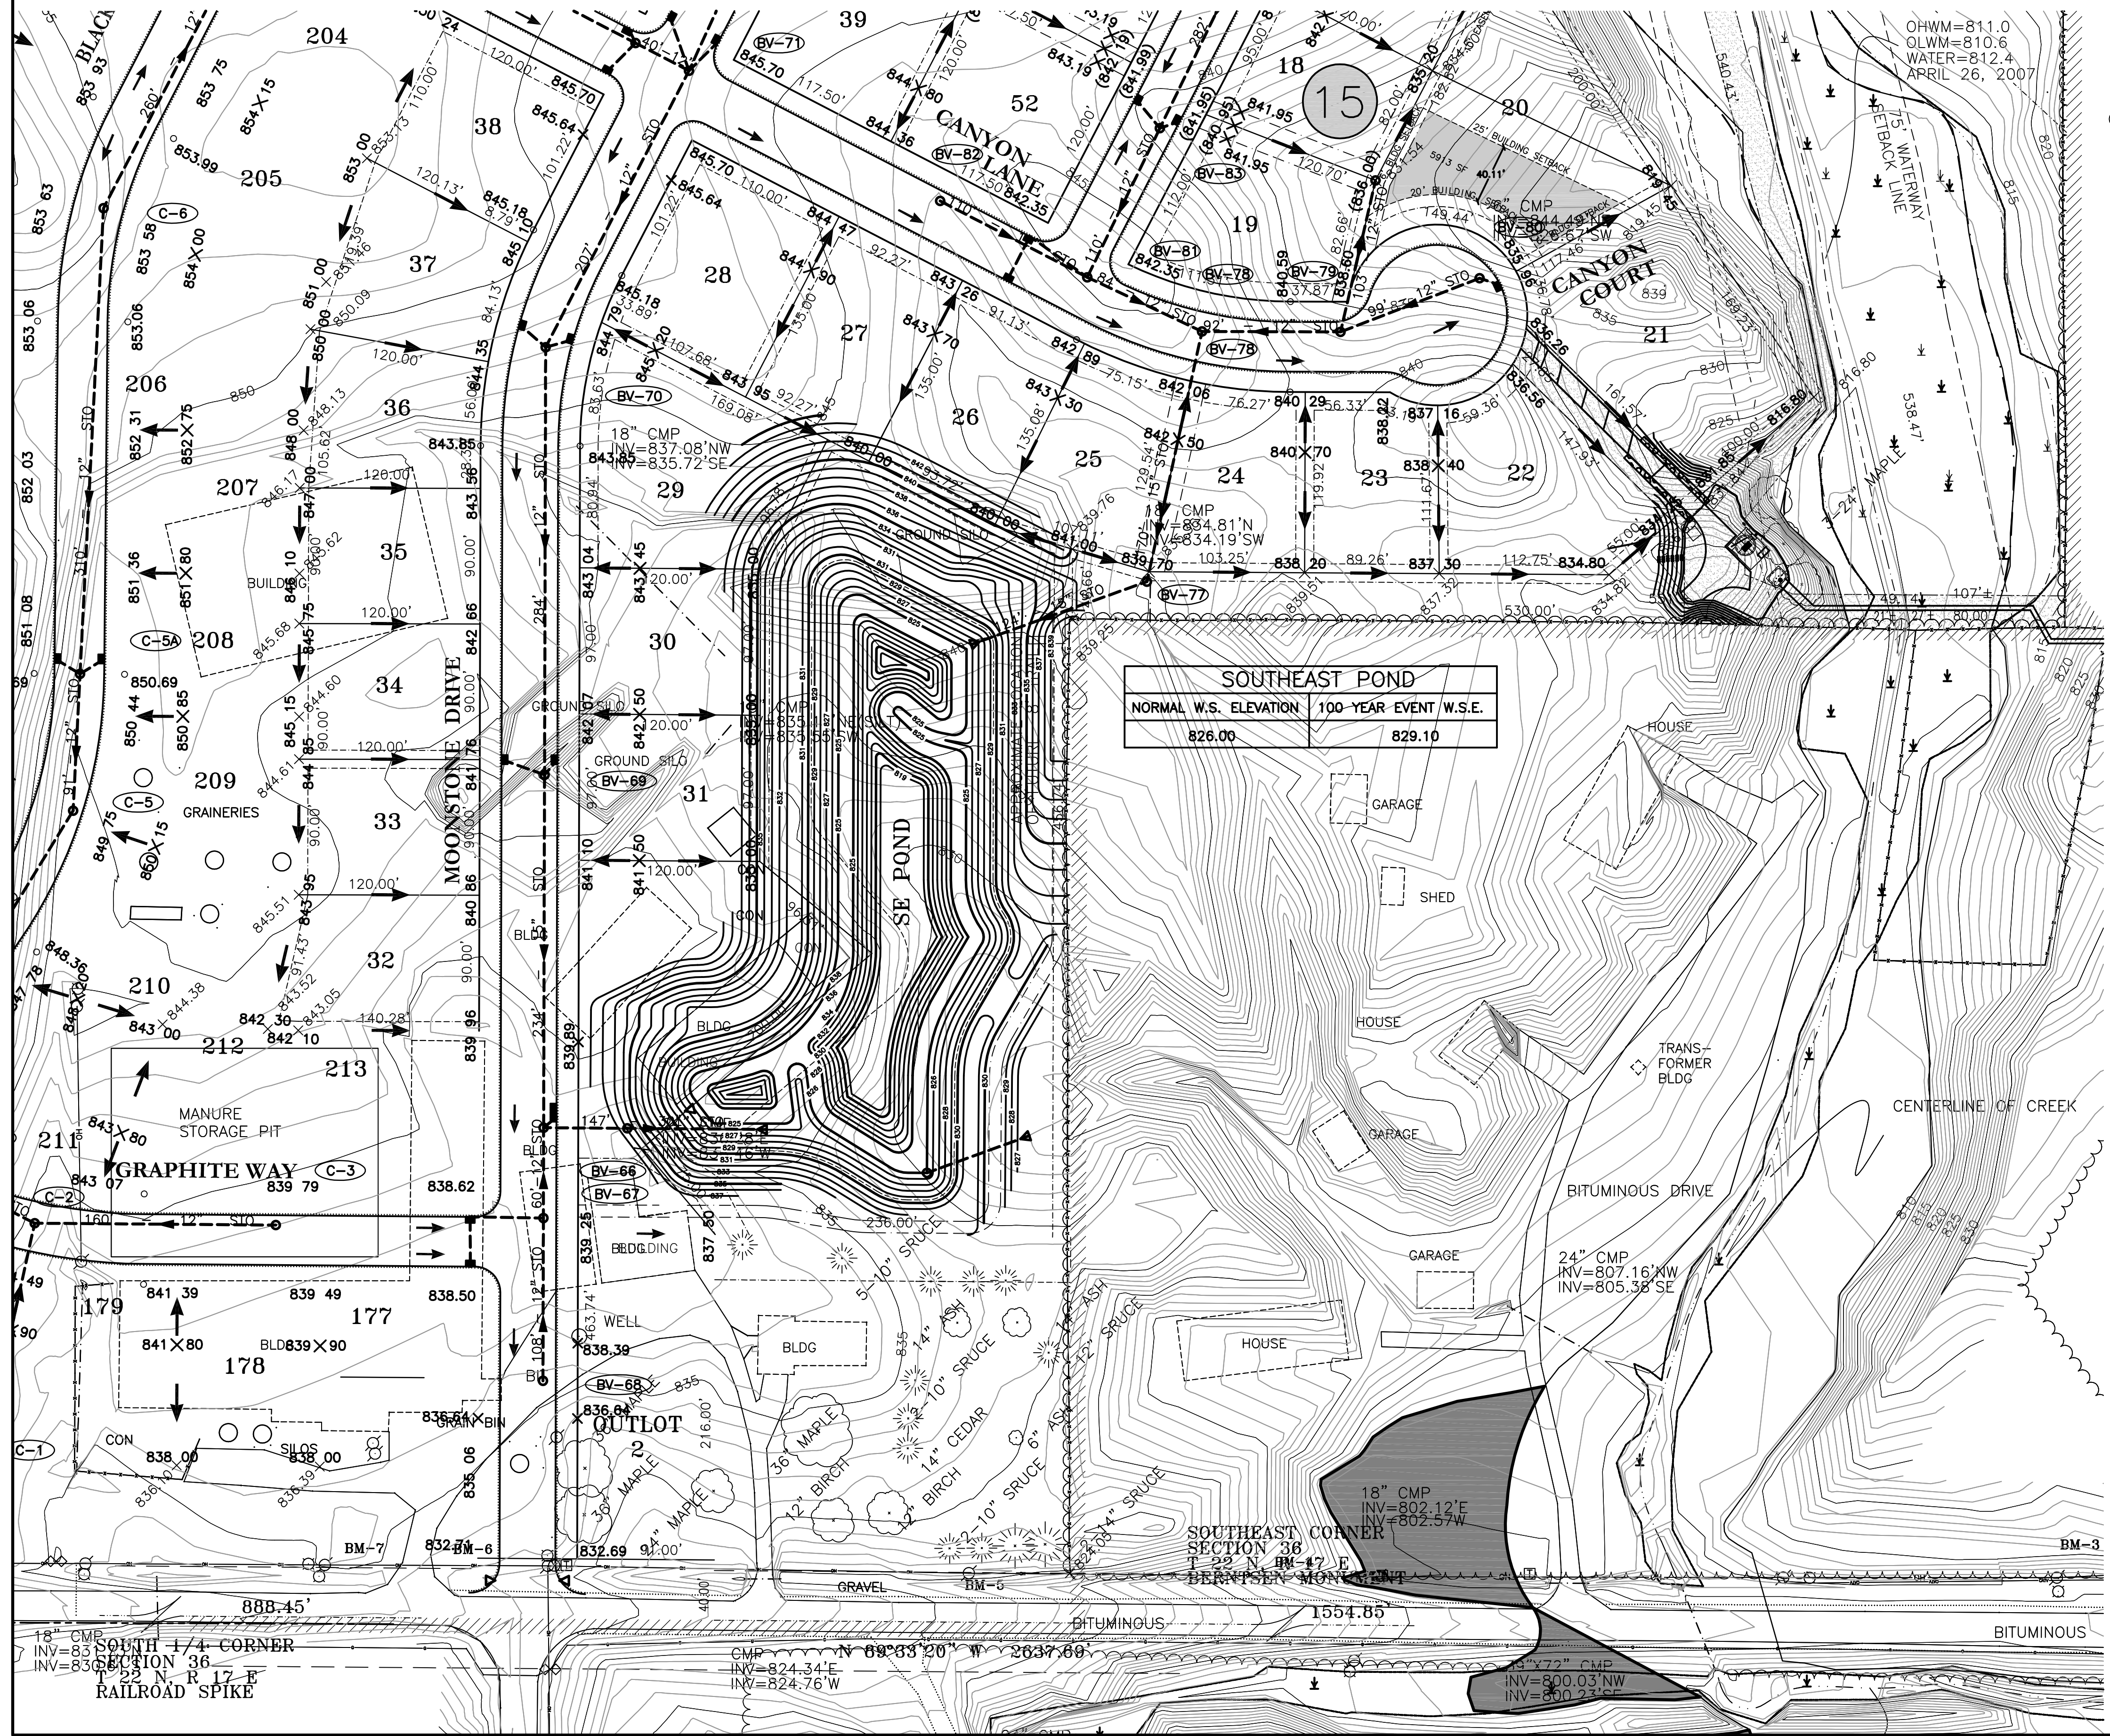

TYPICAL LOT LINE GRADING CROSS SECTION

**TOPOGRAPHIC LEGEND**

1" x 18" IRON PIPE SET	OVERHEAD POWER LINES	GAS VALVE
1-1/4" x 30" REBAR SET	UNDERGROUND ELECTRIC	EXIST. STORM MANHOLE
CHEELED "X" SET	UNDERGROUND TELEPHONE	STORM INLET
3/4" REBAR FOUND	UNDERGROUND FIBEROPTIC CABLE	YARD DRAIN
1" IRON PIPE FOUND	UNDERGROUND GAS	EXIST. SANITARY MANHOLE
1-1/4" REBAR FOUND	UNDERGROUND CABLE TV	EXIST. SAN. SEWER
2" IRON PIPE FOUND	EXIST. FENCE LINE	EXIST. STD. SEWER
CHEELED "X" FOUND	SIGN	EXIST. WATER MAIN
GOVERNMENT CORNER	POWER POLE	EXIST. SPOT ELEVATION
RECORDED AS	GUY	
CONFERRUS TREE	LIGHT POLE	CONTOUR W/ ELEVATION
DECIDUOUS TREE	TELEPHONE PEDESTAL	800.000
WETLANDS	ELECTRIC PEDESTAL	800.000
SOIL BORING	CABLE PEDESTAL	800.000
	EXIST. HYDRANT	FT = 800.00
	WATER VALVE	FIRST FLOOR = 800.00
	WATER STOP BOX	TOPSOIL DEPTH
		INFILTRATION SOIL BORING

**Martenson & Eisele, Inc.**  
Planning  
1377 Midway Road  
Menasha, WI 54952  
www.martenson-eisele.com  
info@martenson-eisele.com  
Environmental  
Surveying  
Engineering  
Architecture  
920.731.0381 1.800.236.0381

DRAWN BY	CIRC	DATE	CHECKED	APPROVED	REVISION	
					NO.	DATE

## FINAL DRAINAGE PLAN (SOUTH) GLACIER RIDGE (PHASE 1) LOTS 1-64

SCALE	DATE
1"=60'	12-11-07
COMPUTER FILE	
663001/Design/663001de.dwg	

DRAWING NO.  
663-001 D.P. (S)